


# *Appendix 1*

---

ARCHITECTURAL DRAWINGS



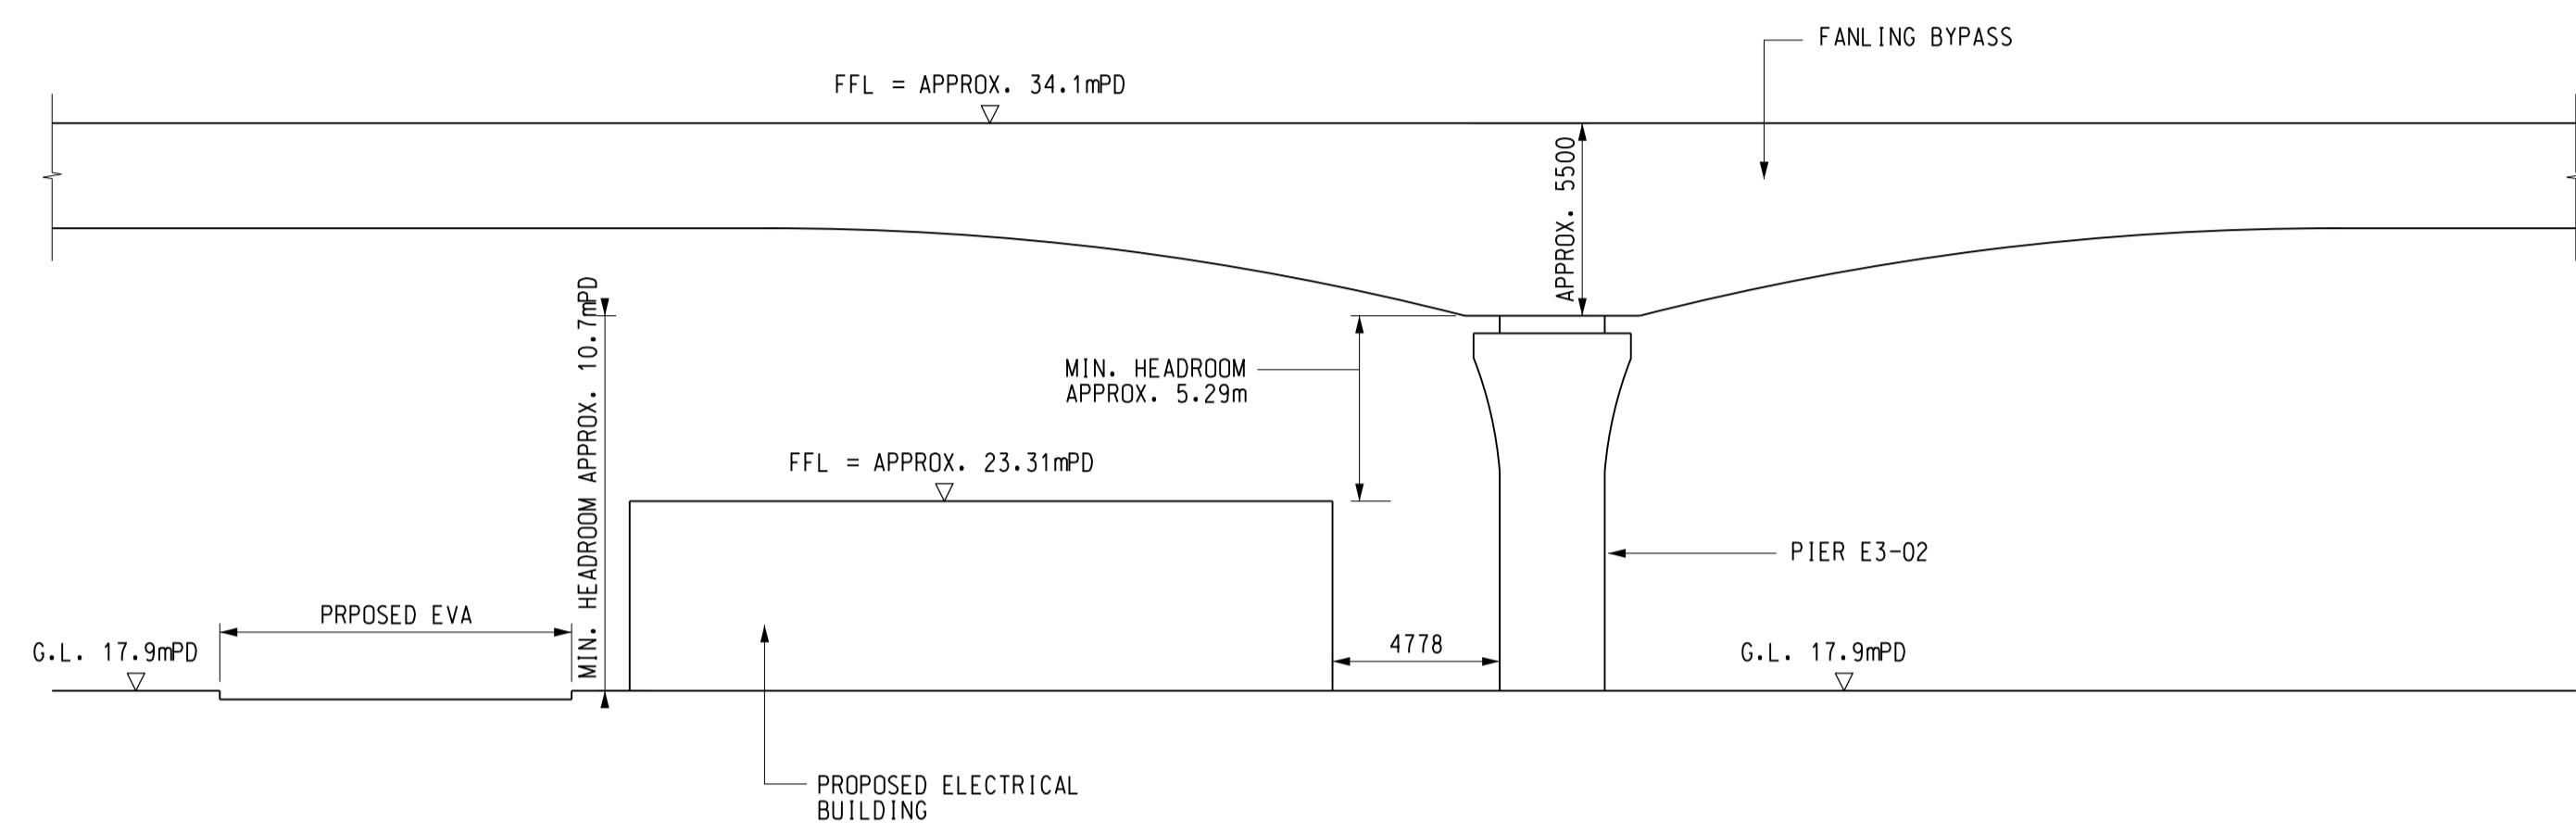

SECTION 03  
 SCALE 1 : 200  
 AIS-002

Rev.	Date	Drawn	Description	Checked	Approved
------	------	-------	-------------	---------	----------

Employer



水務署  
Water Supplies Department

Project

AGREEMENT NO. CE47/2023 (WS)  
 IMPROVEMENT OF WATER SUPPLY TO  
 NORTHERN NEW TERRITORIES  
 - INVESTIGATION, DESIGN AND  
 CONSTRUCTION

Title

E&M BUILDING ELEVATIONS

Consultant





Designed	RL	Checked	MK
Drawn	CL	Approved	TKT

Scale	A1	Status	Rev
1 : 200		DESIGN DRAWING	-


Drawing No.

CE47-AIS-103

© Copyright reserved

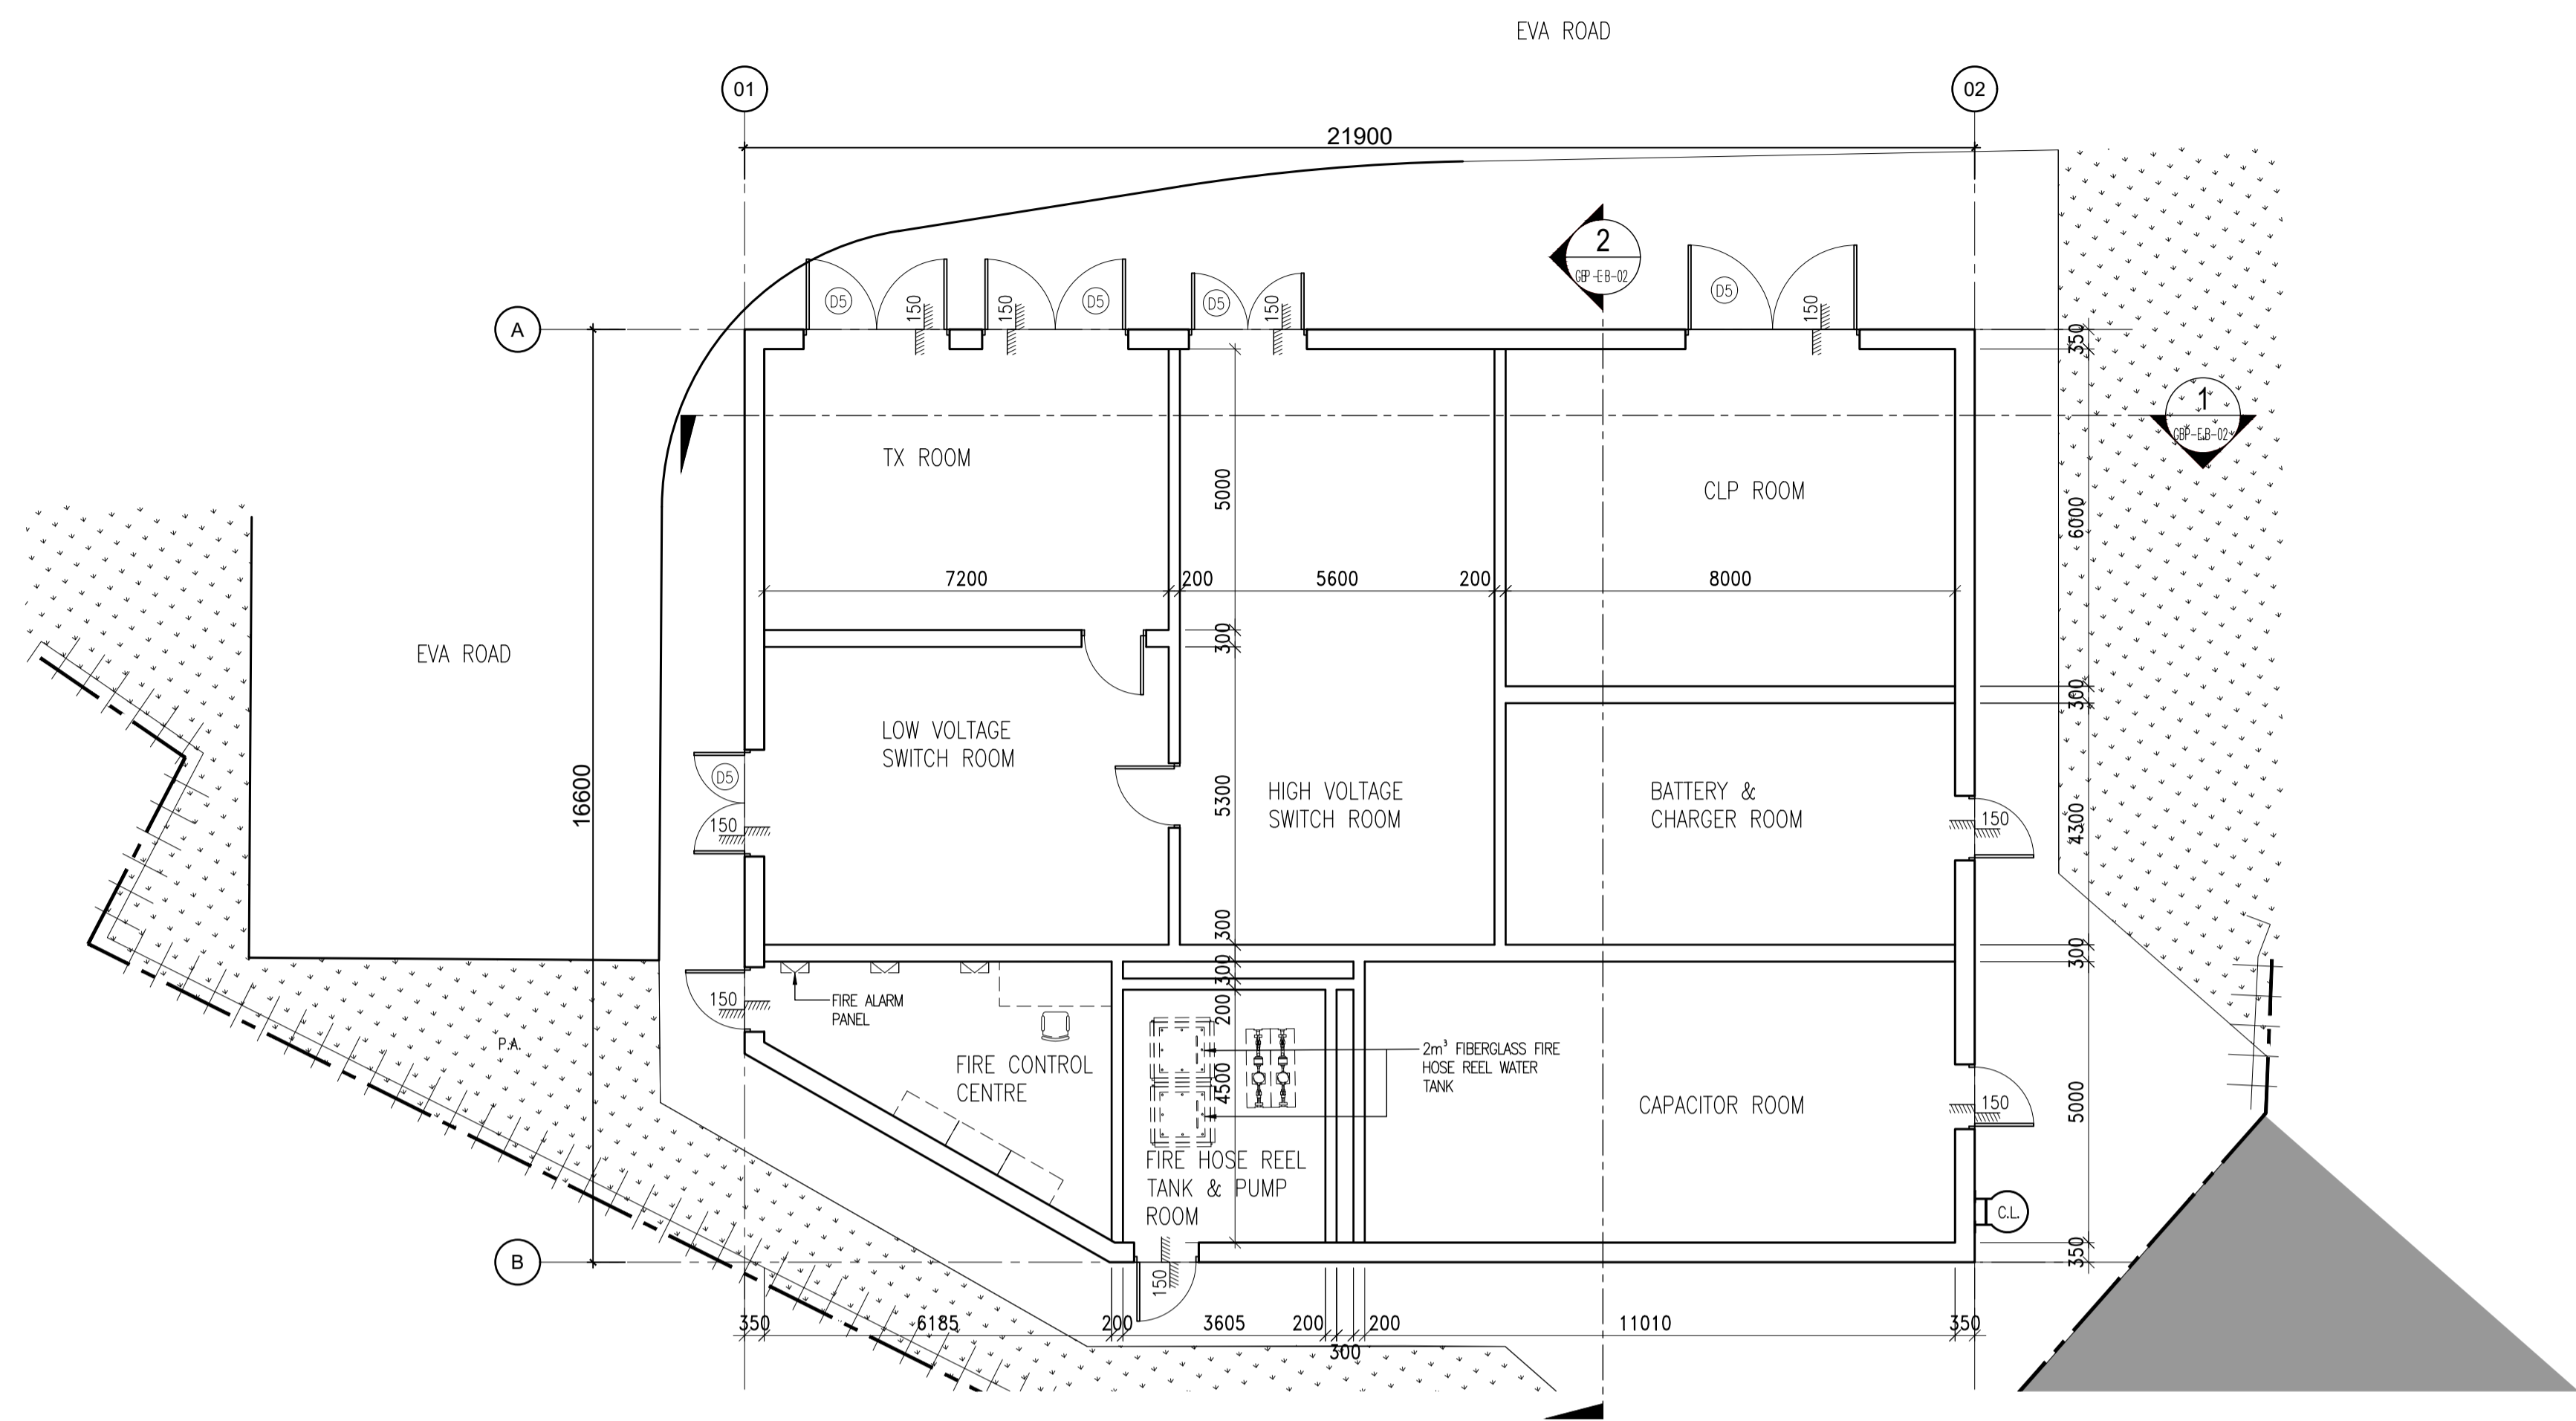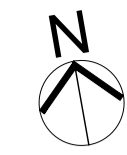


**1** ELECTRICAL BUILDING GROUND FLOOR PLAN  
SCALE 1:100@A1

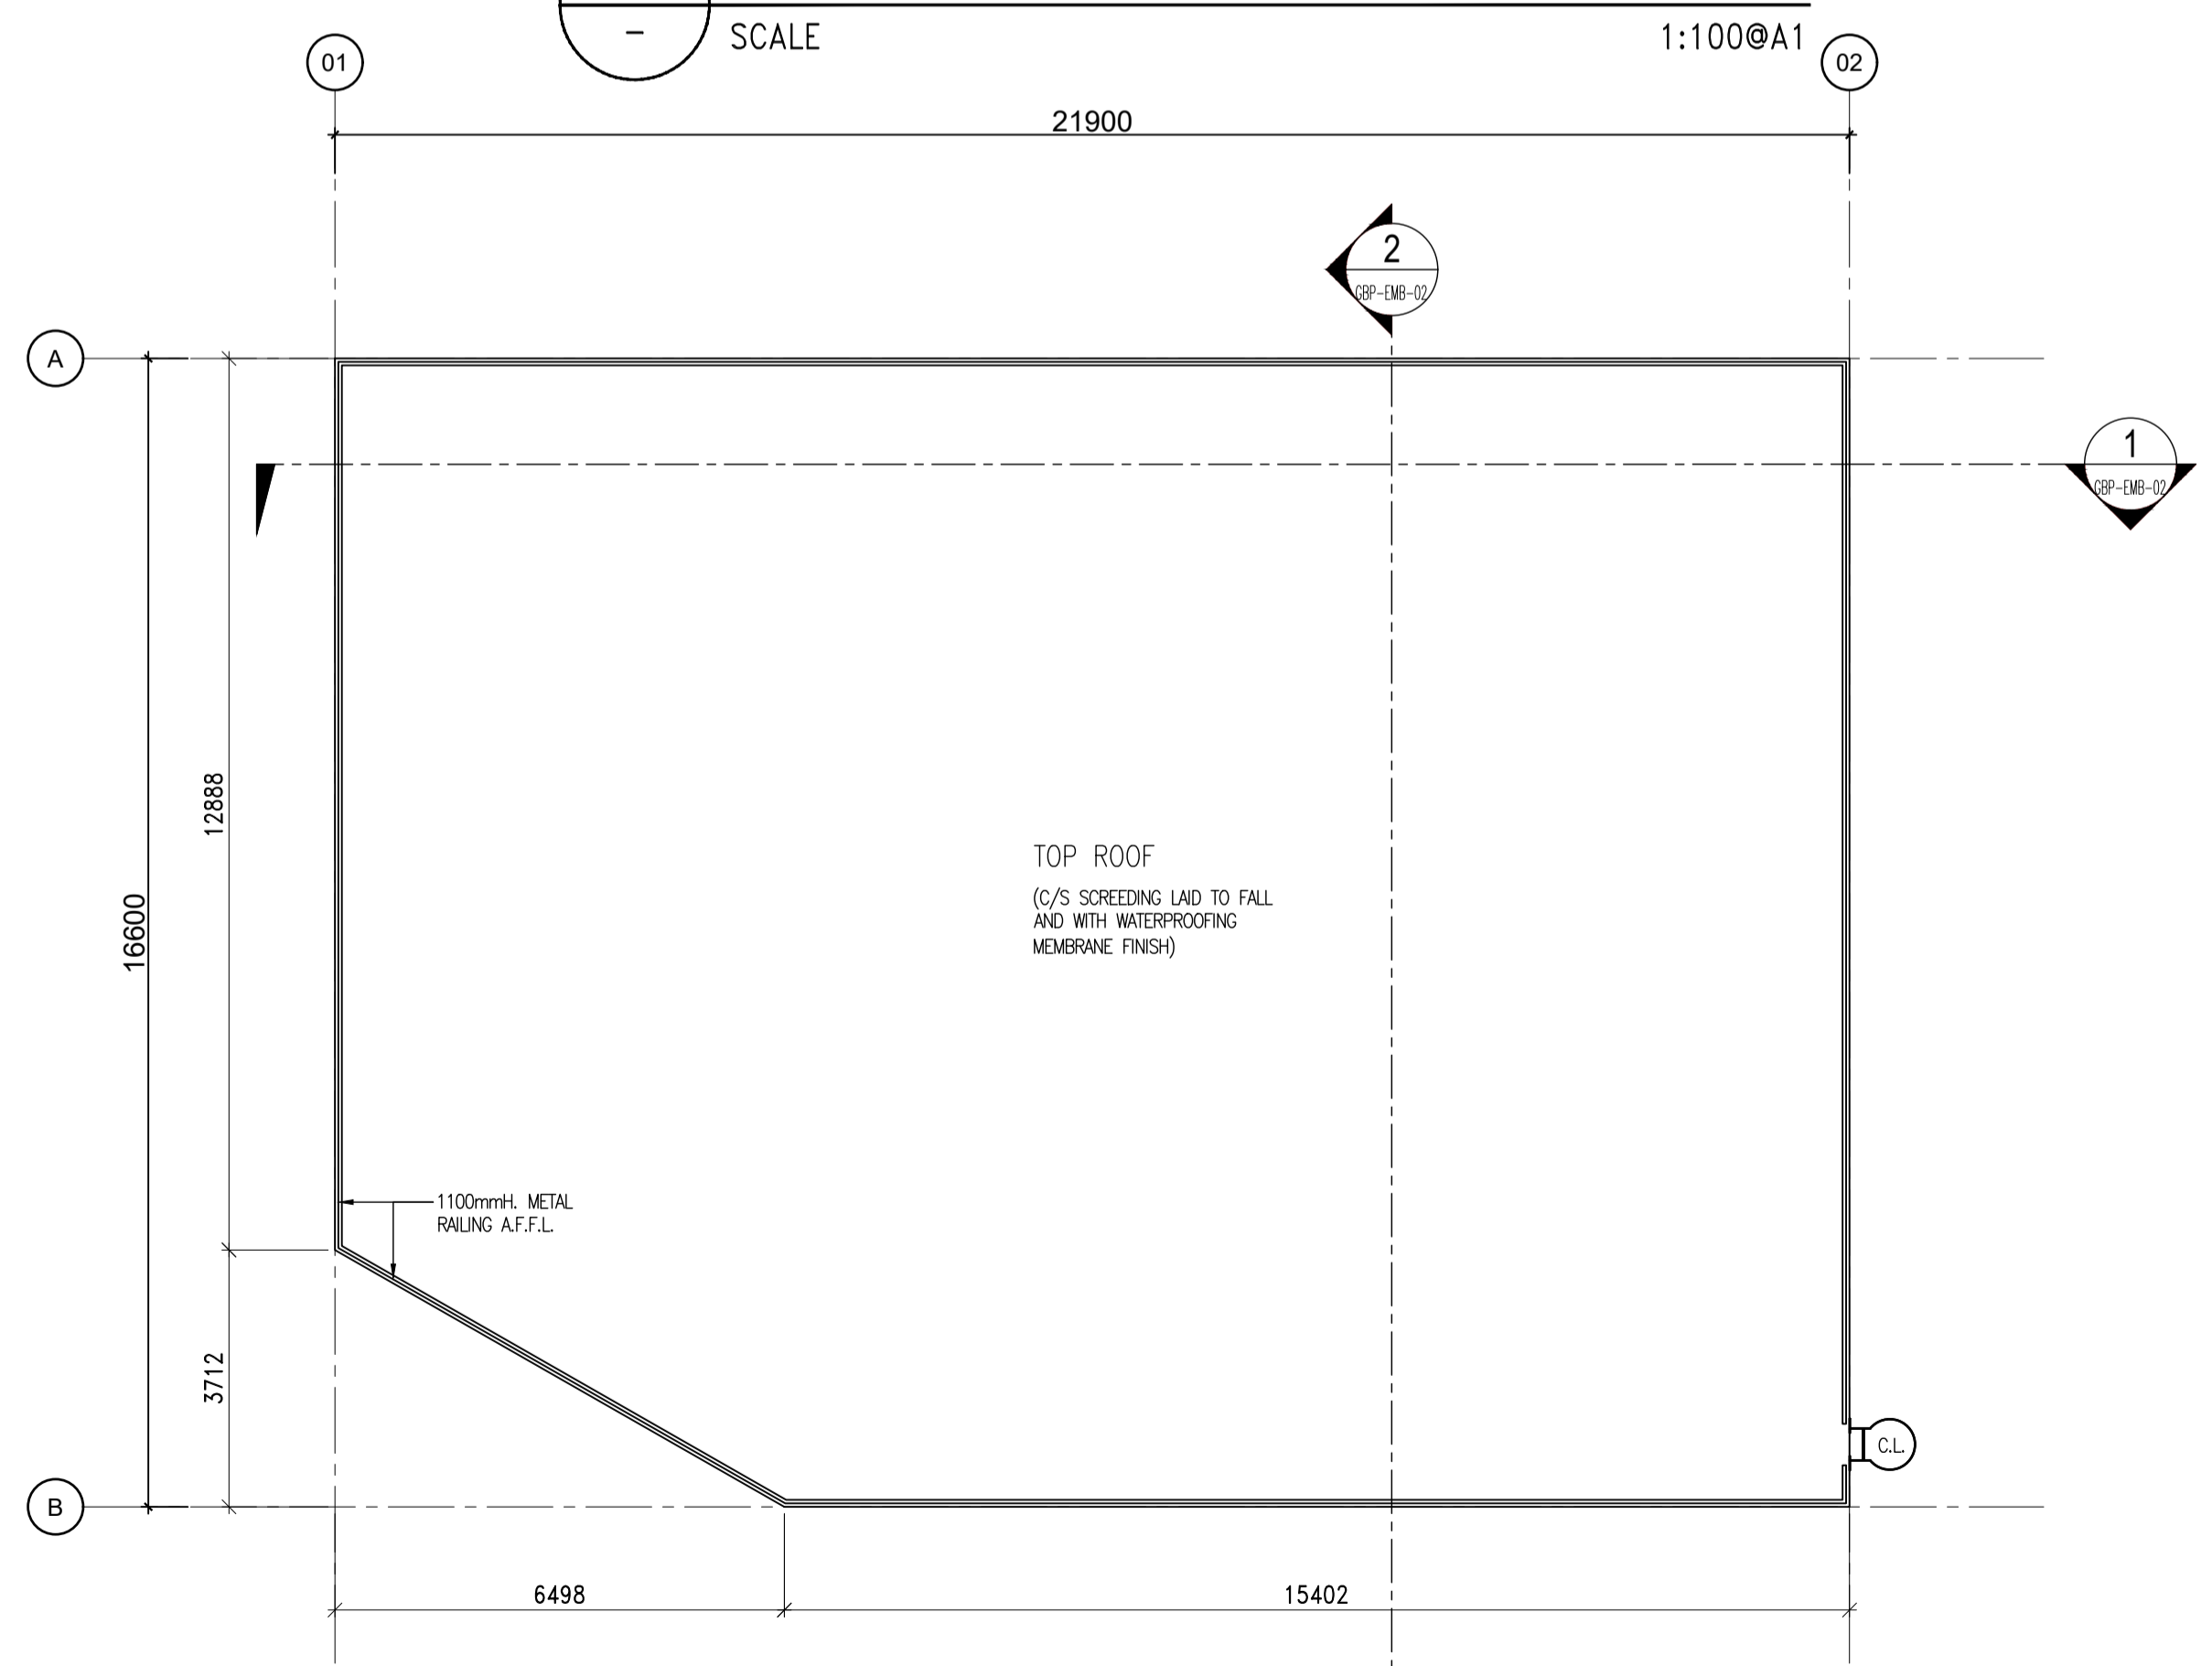

**2** ELECTRICAL BUILDING ROOF PLAN  
SCALE 1:100@A1

Rev.	Date	Drawn	Description	Checked	Approved
-	XX/12/24	JL	FIRST SUBMISSION		

Employer




Project

AGREEMENT NO. CE47/2023 (WS)  
IMPROVEMENT OF WATER SUPPLY TO  
NORTHERN NEW TERRITORIES  
- INVESTIGATION, DESIGN AND  
CONSTRUCTION

Title

ELECTRICAL BUILDING - PLANS

Consultant




Designed	-	Checked	KB
Drawn	JL	Approved	KB

Scale	A1	Status	Rev
1:100		DESIGN	-


Drawing No.

IWS-GBP-EB-01

© Copyright reserved

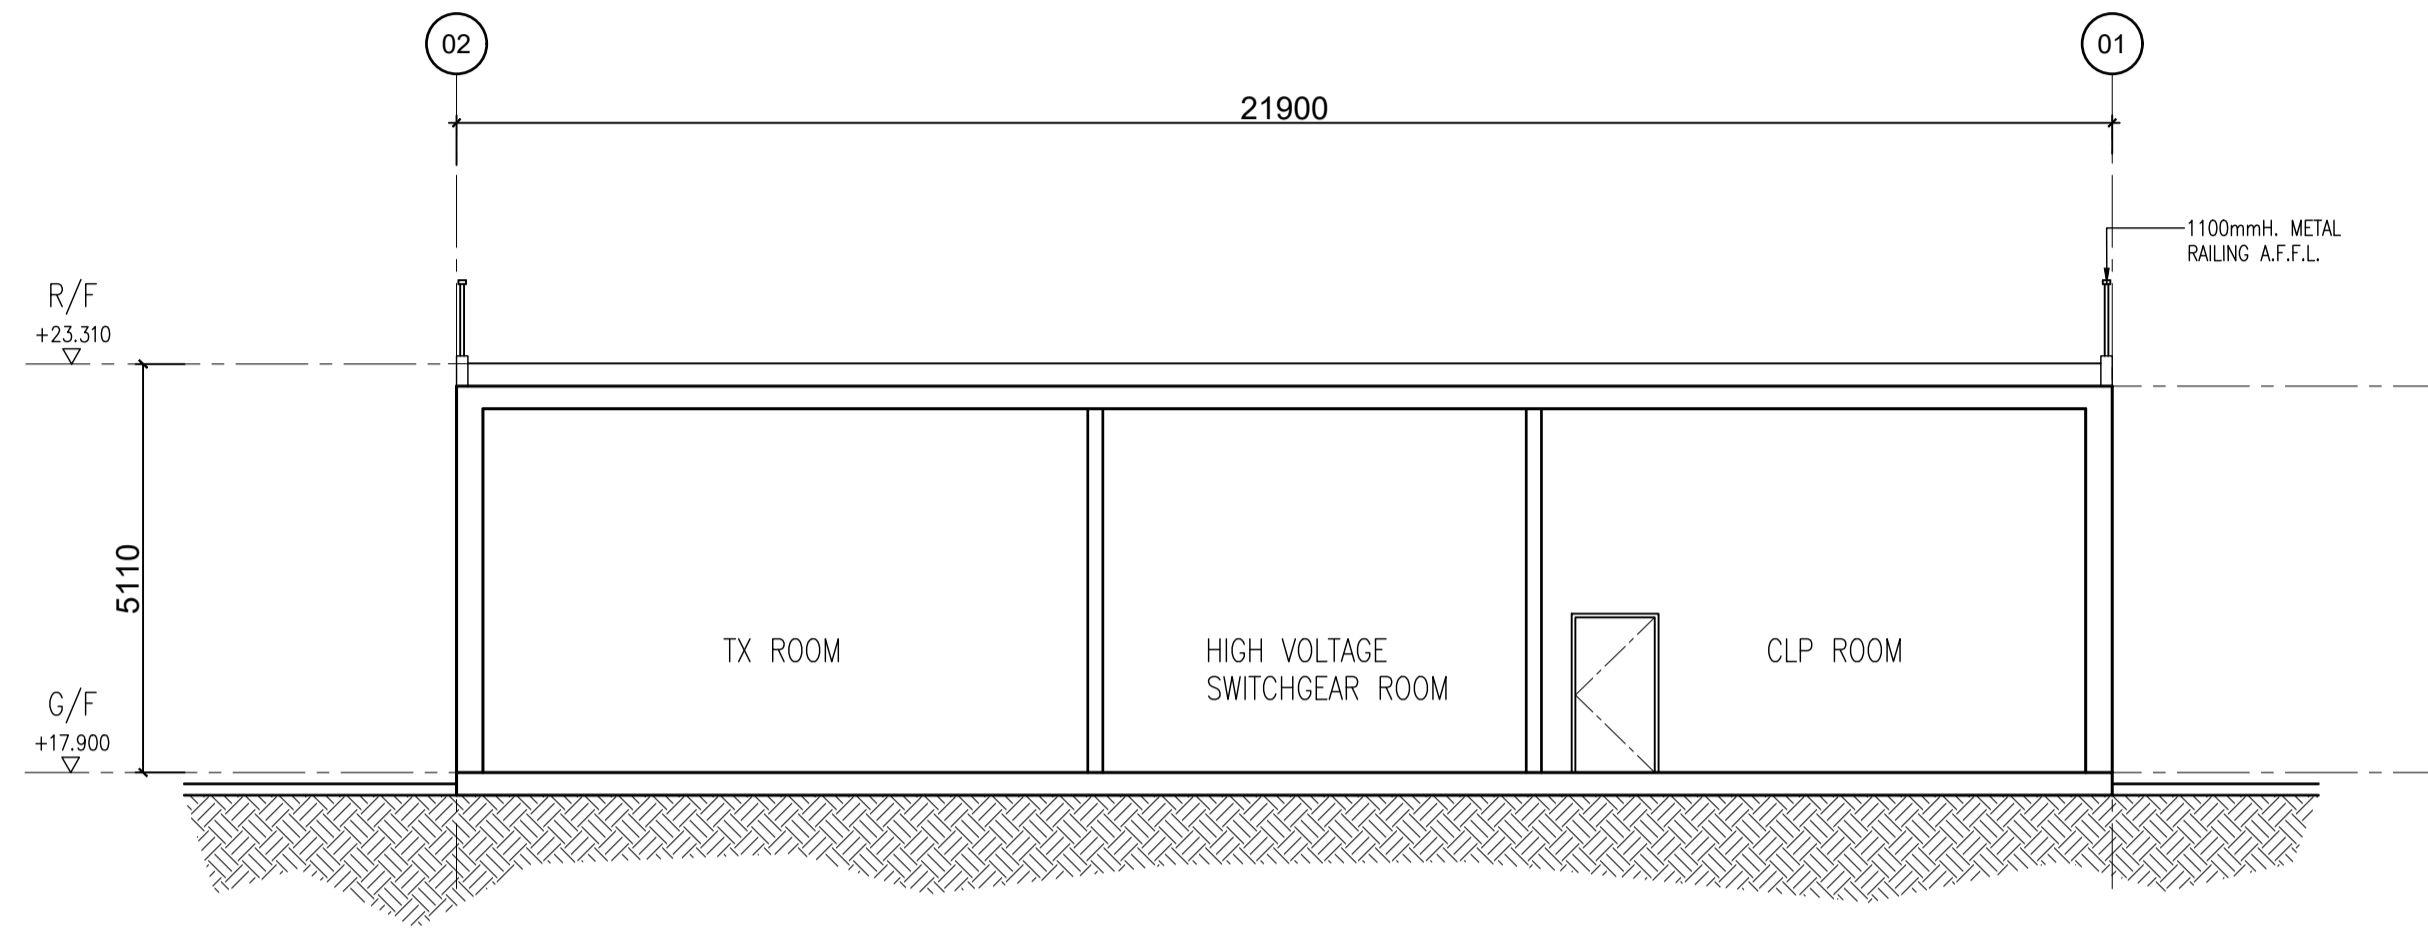

1 SECTION A  
SCALE 1:100@A1

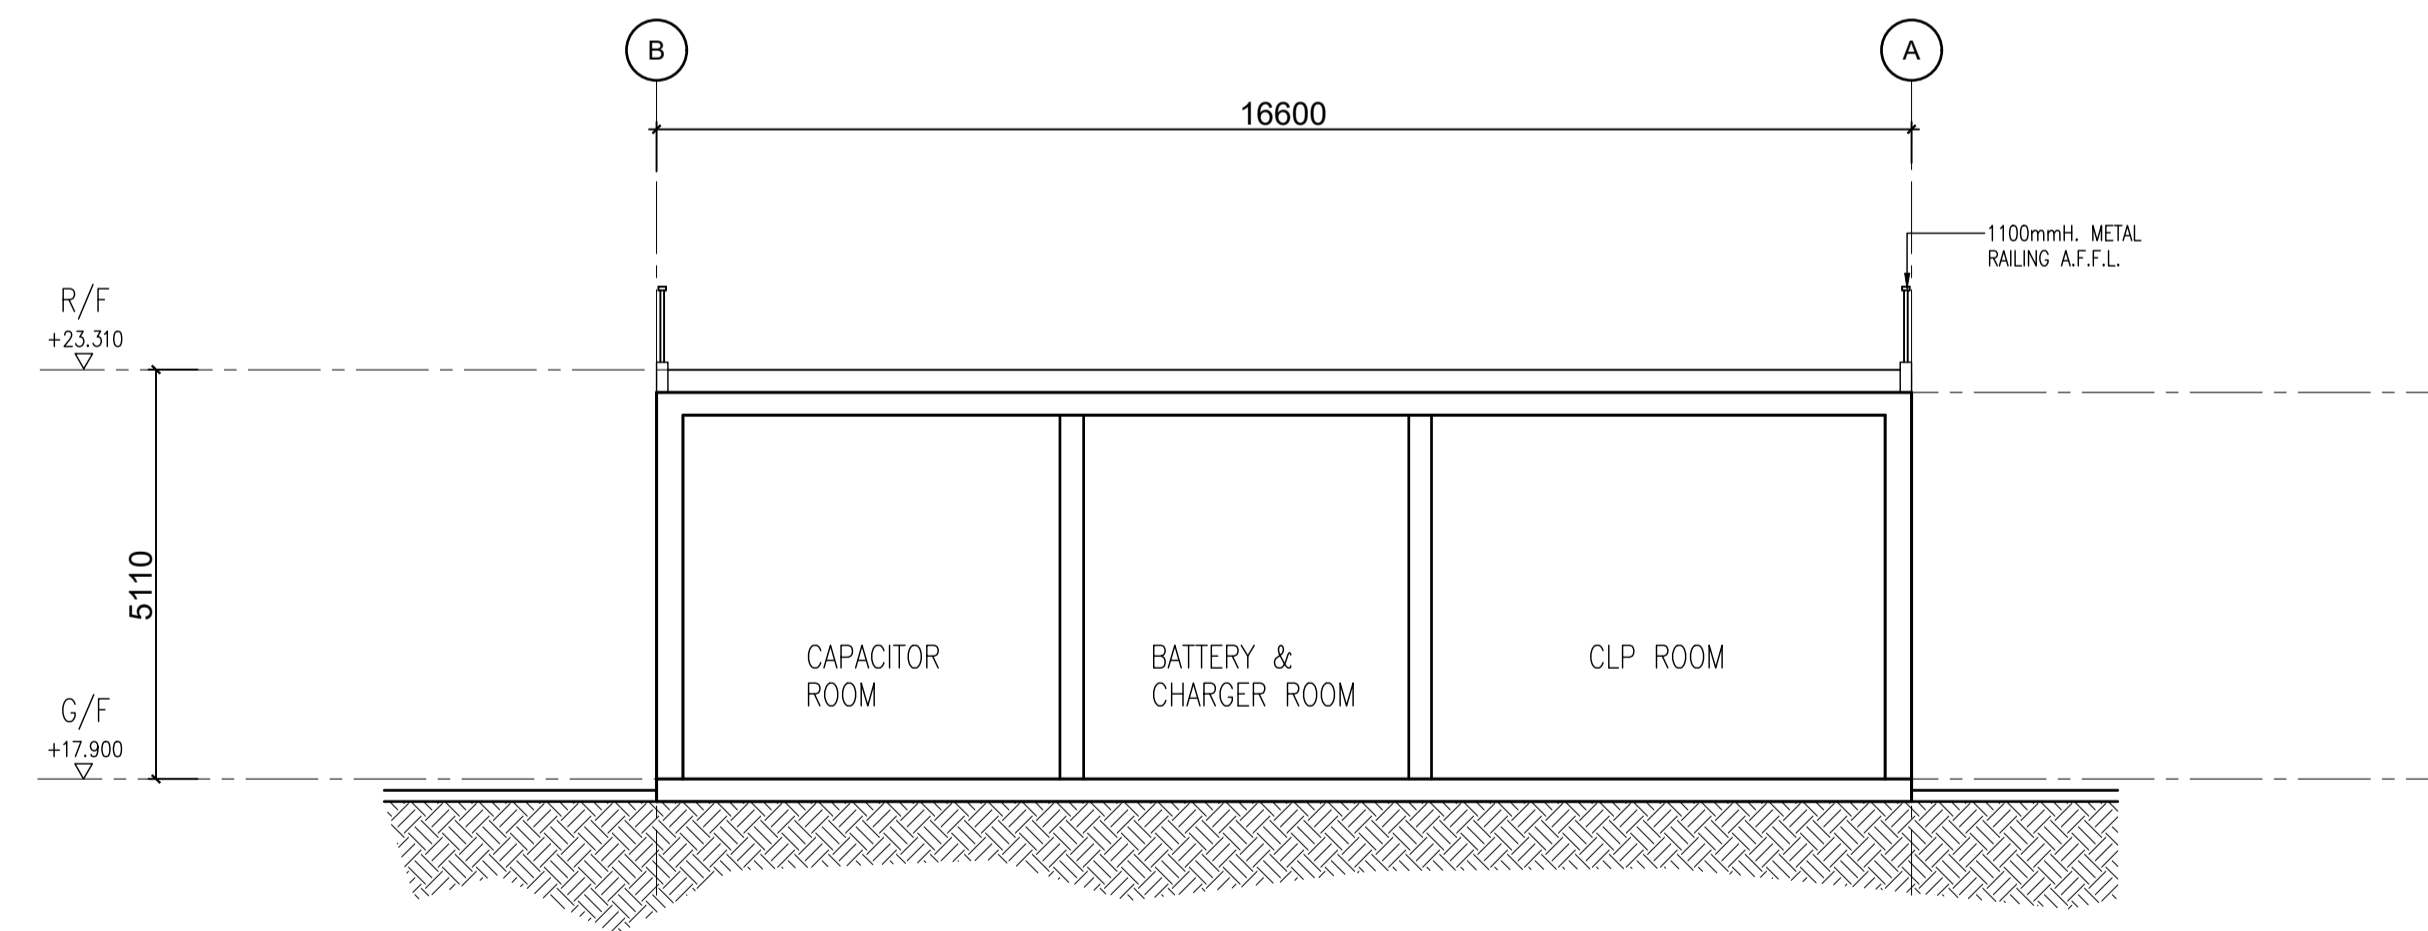

2 SECTION B  
SCALE 1:100@A1

Rev.	Date	Drawn	Description	Checked	Approved
-	XX/12/24	JL	FIRST SUBMISSION		

Employer



水務署  
Water Supplies Department

Project  
AGREEMENT NO. CE47/2023 (WS)  
IMPROVEMENT OF WATER SUPPLY TO  
NORTHERN NEW TERRITORIES  
- INVESTIGATION, DESIGN AND  
CONSTRUCTION

Title  
ELECTRICAL BUILDING - SECTIONS


Consultant



Designed	-	Checked	KB
Drawn	JL	Approved	KB
Scale	A1	Status	Rev
1:100		DESIGN	-

Drawing No.  
IWS-GBP-EB-02

© Copyright reserved

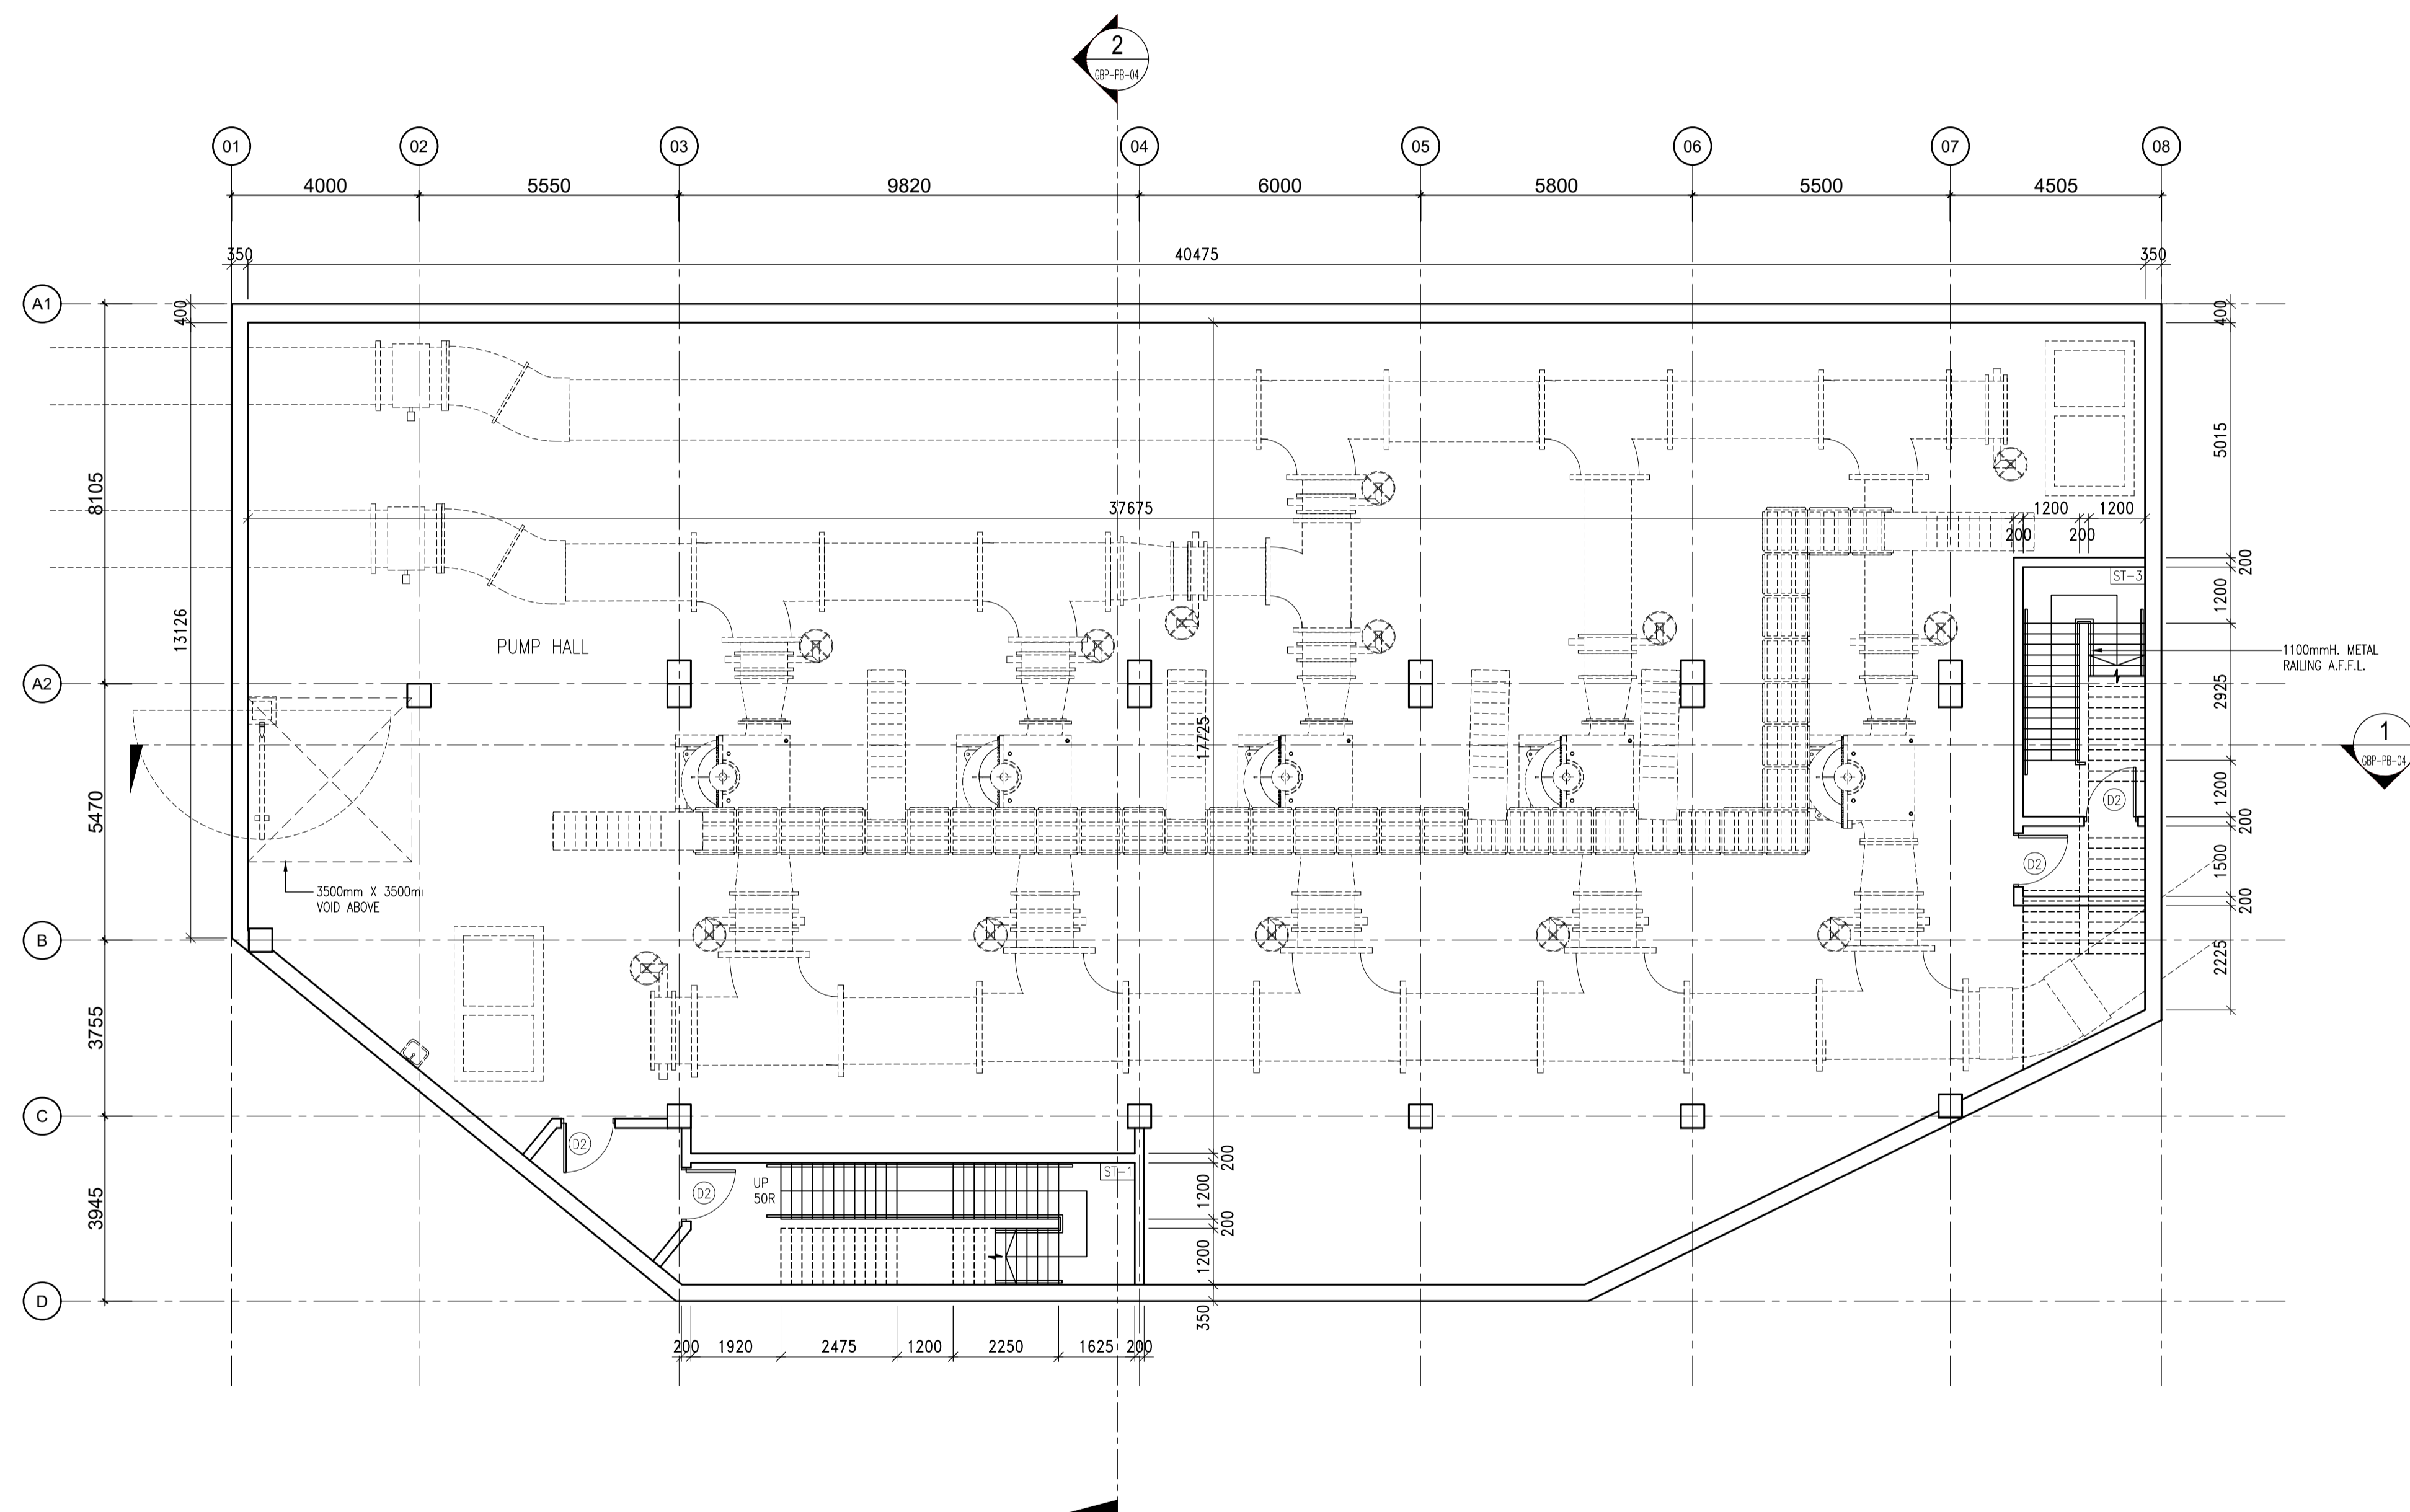

**1** PUMP BUILDING BASEMENT FLOOR PLAN  
SCALE 1:100@A1

Rev.	Date	Drawn	Description	Checked	Approved
-	XX/12/24	JL	FIRST SUBMISSION		

Employer

水務署  
Water Supplies Department

Project  
AGREEMENT NO. CE47/2023 (WS)  
IMPROVEMENT OF WATER SUPPLY TO  
NORTHERN NEW TERRITORIES  
- INVESTIGATION, DESIGN AND  
CONSTRUCTION

Title  
PUMP BUILDING - BASEMENT FLOOR PLAN


Consultant

asia  
infrastructure  
solutions


Designed	-	Checked	KB
Drawn	JL	Approved	KB
Scale	A1	Status	Rev
1:100		DESIGN	-

Drawing No.  
IWS-GBP-PB-01  
© Copyright reserved



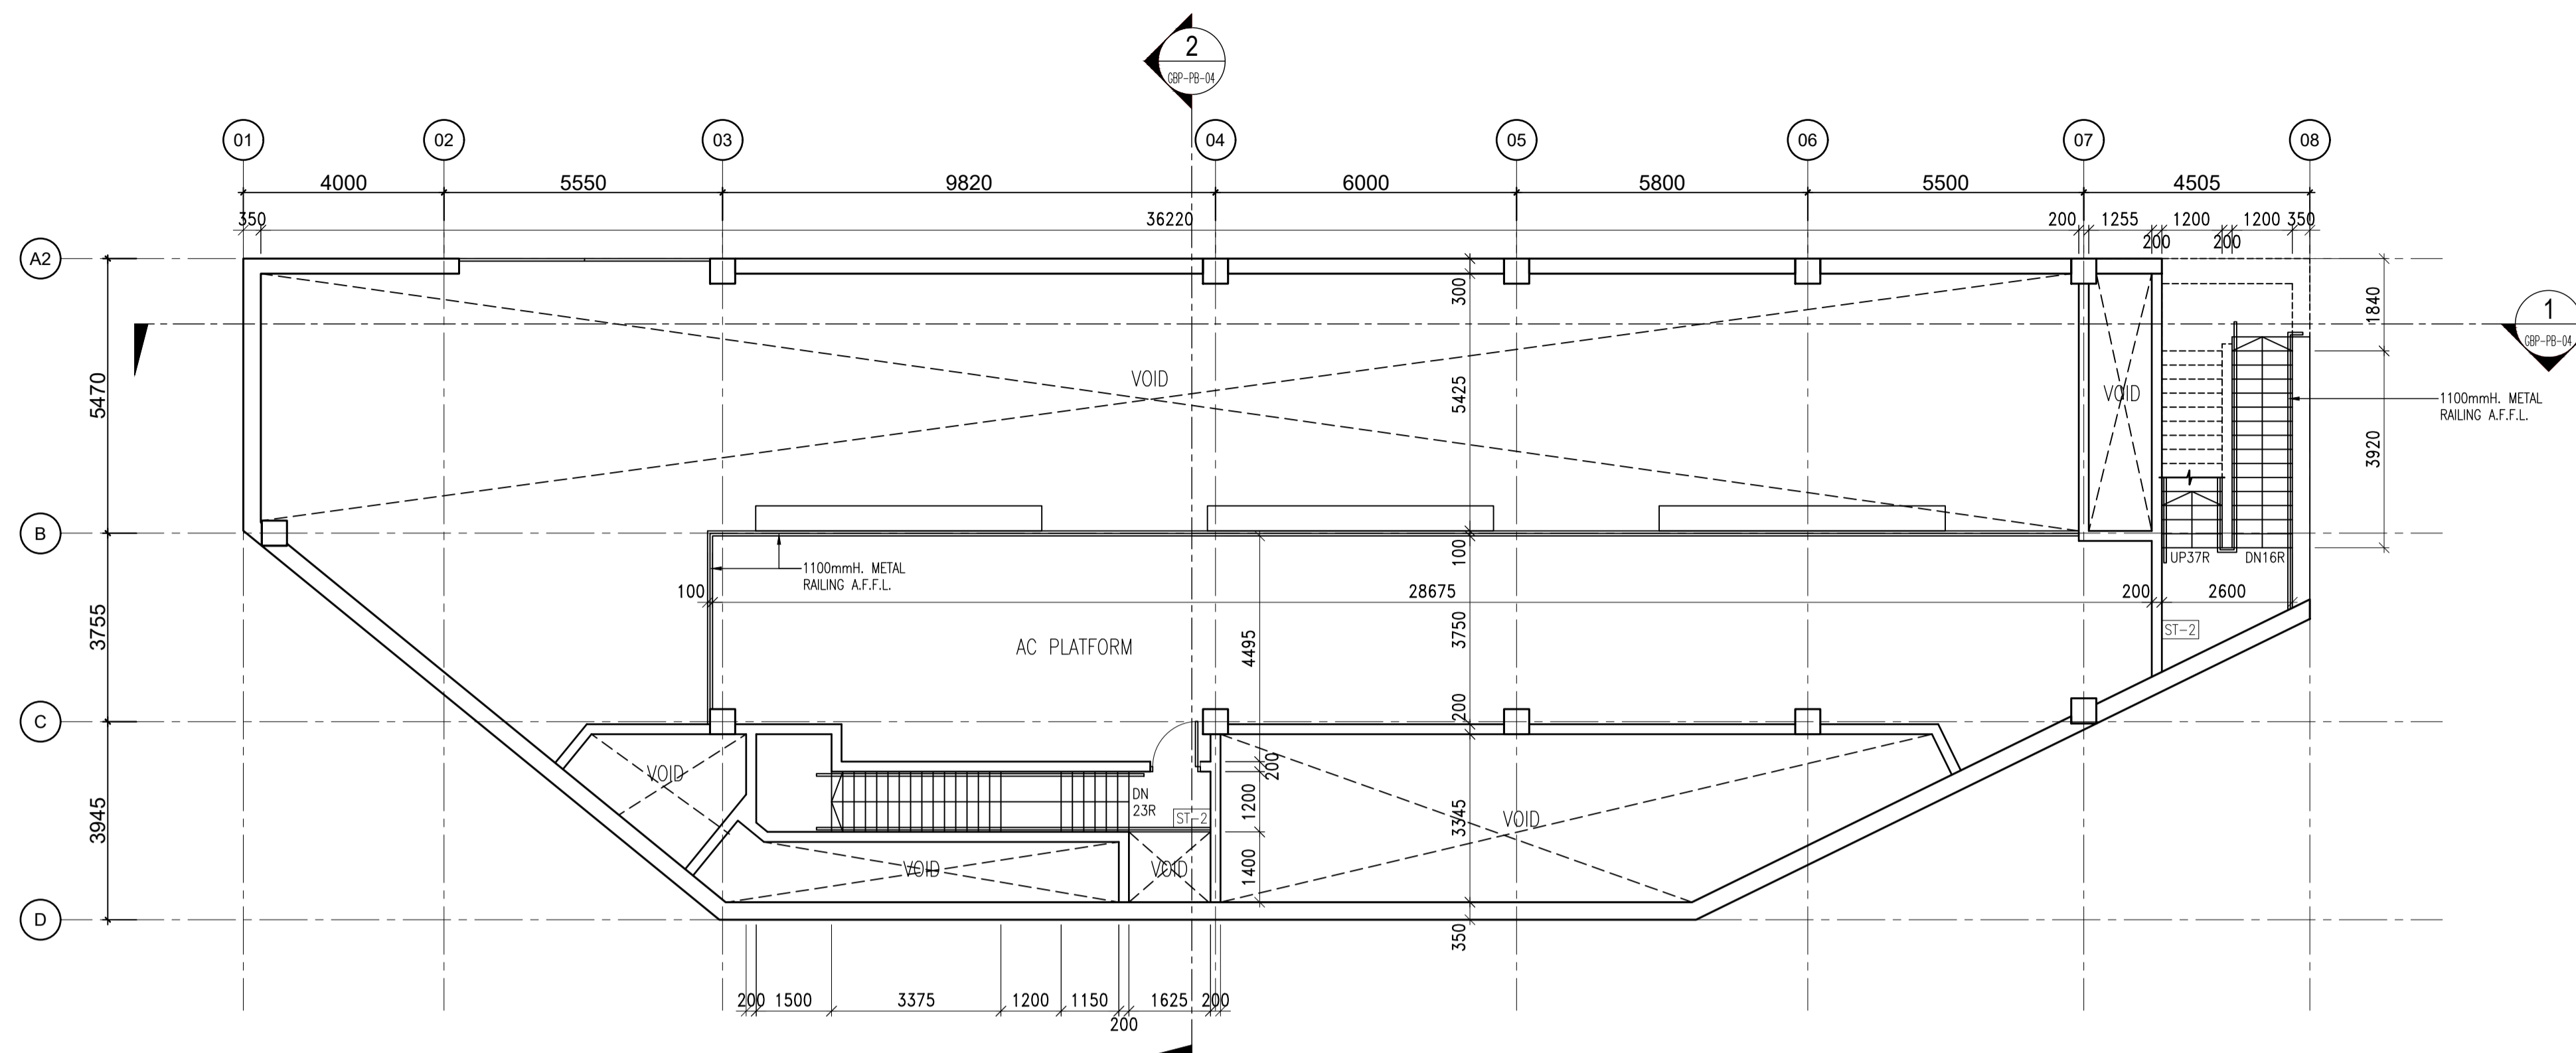

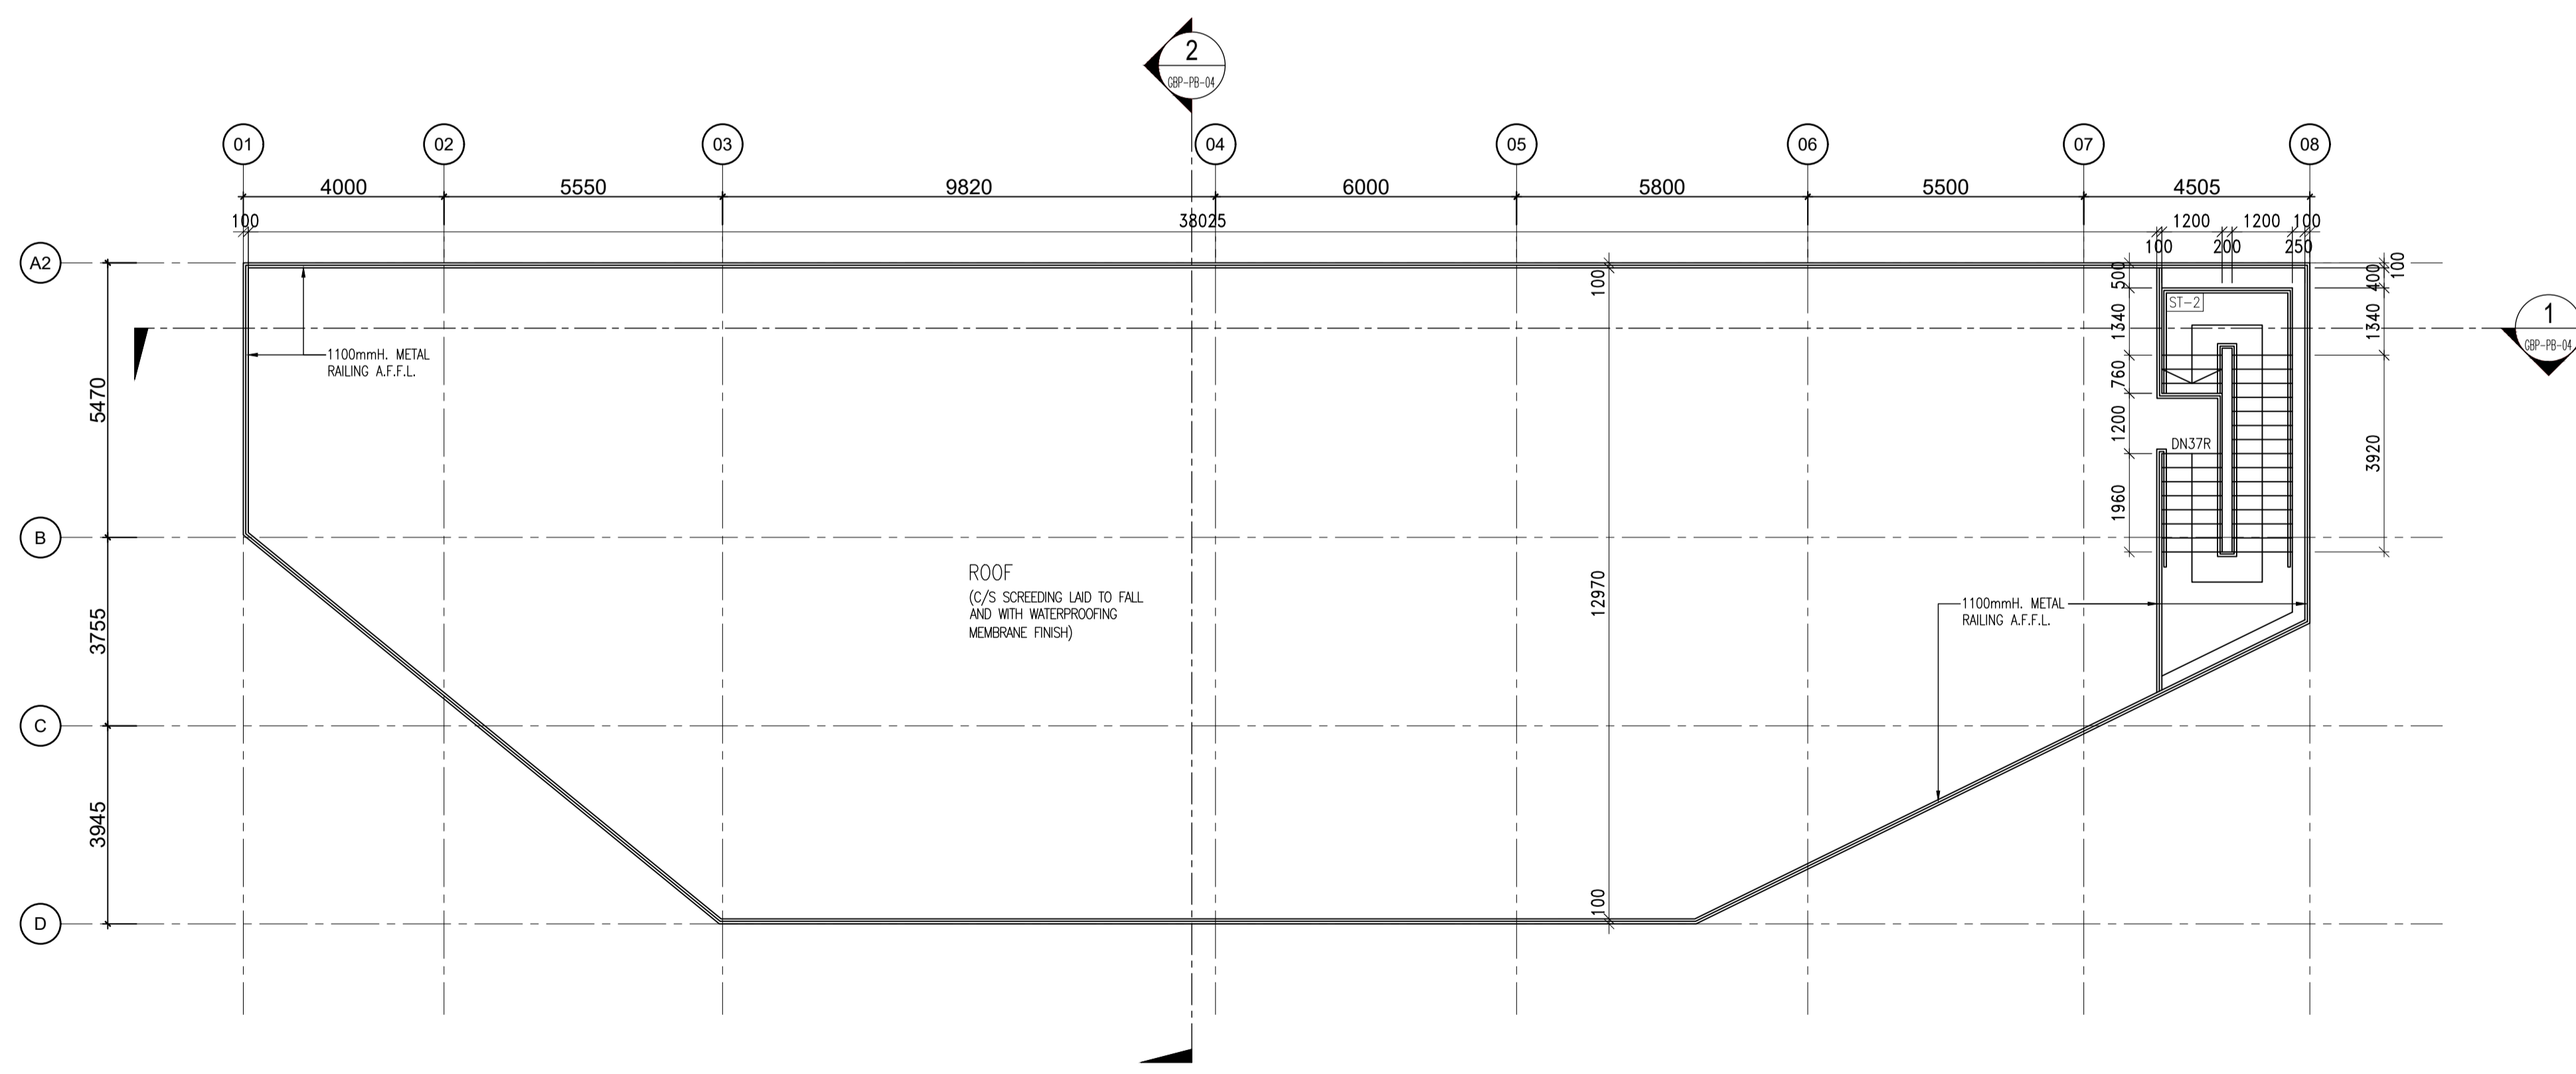

**1** PUMP BUILDING MEZZANINE FLOOR PLAN  
 - SCALE 1:100@A1




**2** PUMP BUILDING ROOF PLAN  
 - SCALE 1:100@A1


Rev.	Date	Drawn	Description	Checked	Approved
-	XX/12/24	JL	FIRST SUBMISSION		
Employer					
 水務署 Water Supplies Department					
Project					
AGREEMENT NO. CE47/2023 (WS) IMPROVEMENT OF WATER SUPPLY TO NORTHERN NEW TERRITORIES - INVESTIGATION, DESIGN AND CONSTRUCTION					
Title					
PUMP BUILDING - MEZZANINE FLOOR AND ROOF PLAN					
Consultant					
					
Designed	-	Checked		KB	
Drawn	JL	Approved		KB	
Scale	A1	Status		Rev	
1:100		DESIGN		-	
Drawing No.					
IWS-GBP-PB-03					
© Copyright reserved					

PRINTED BY: 06/01/2024 6:13:49 PM  
 FILENAME: P:\H24013\CE-472023 (WS)-IMPROVEMENT OF WATER SUPPLY TO NORTHERN NEW TERRITORIES\06\_DRAWING\SD\IWS-GBP-PB-03.DWG



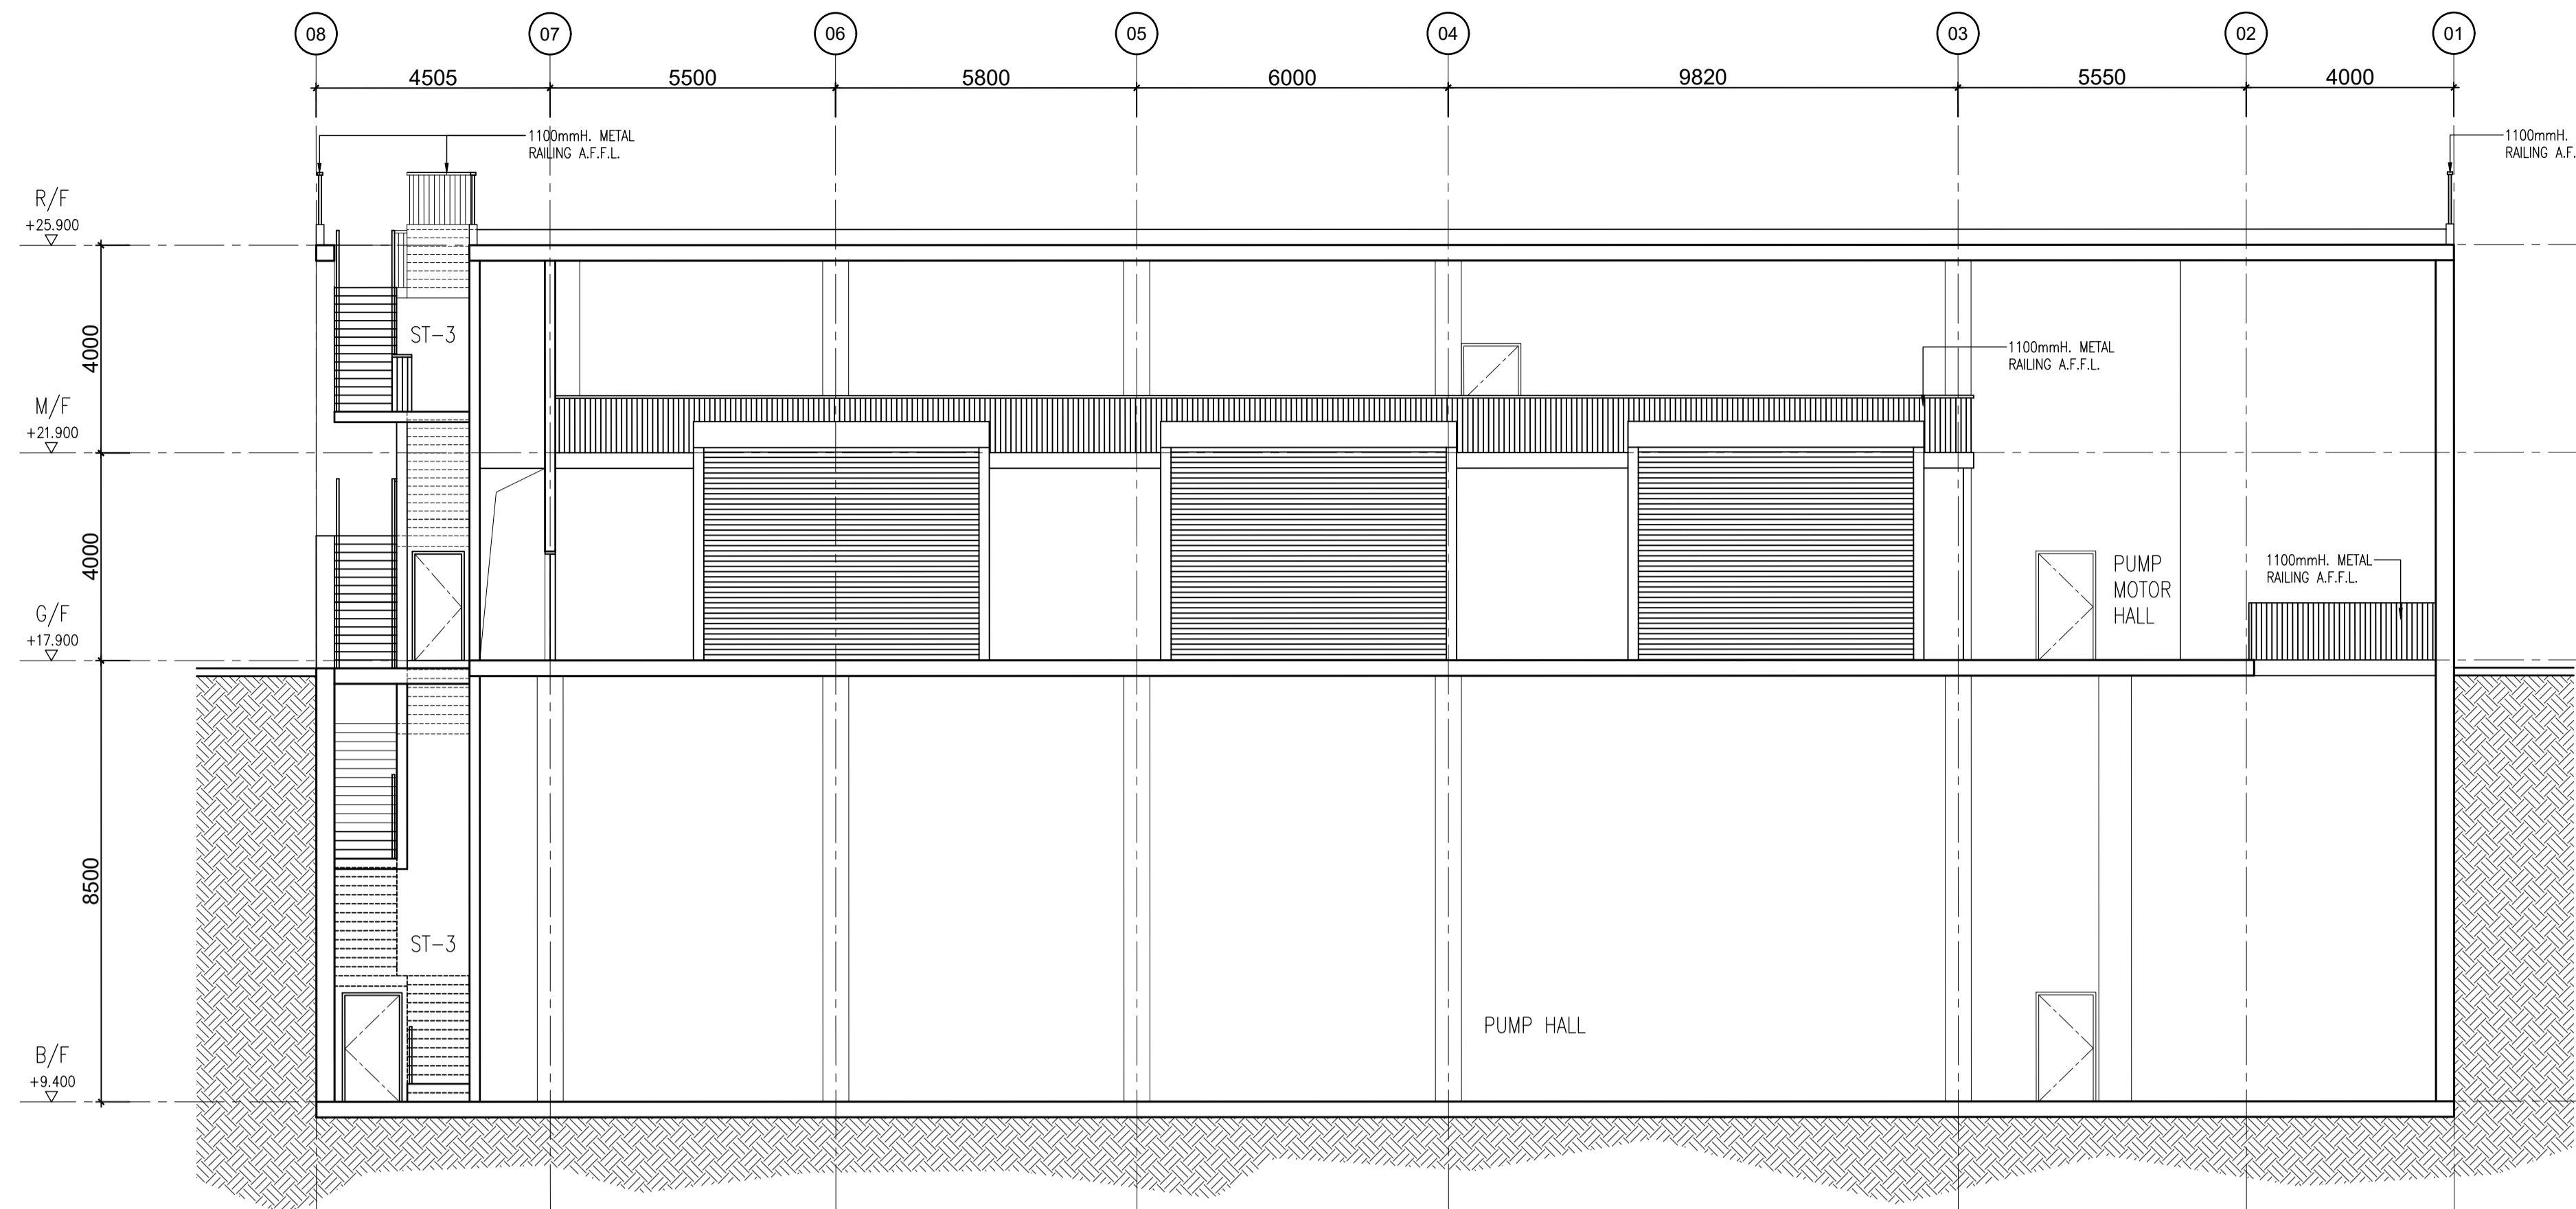

1 SECTION A  
SCALE 1:100@A1

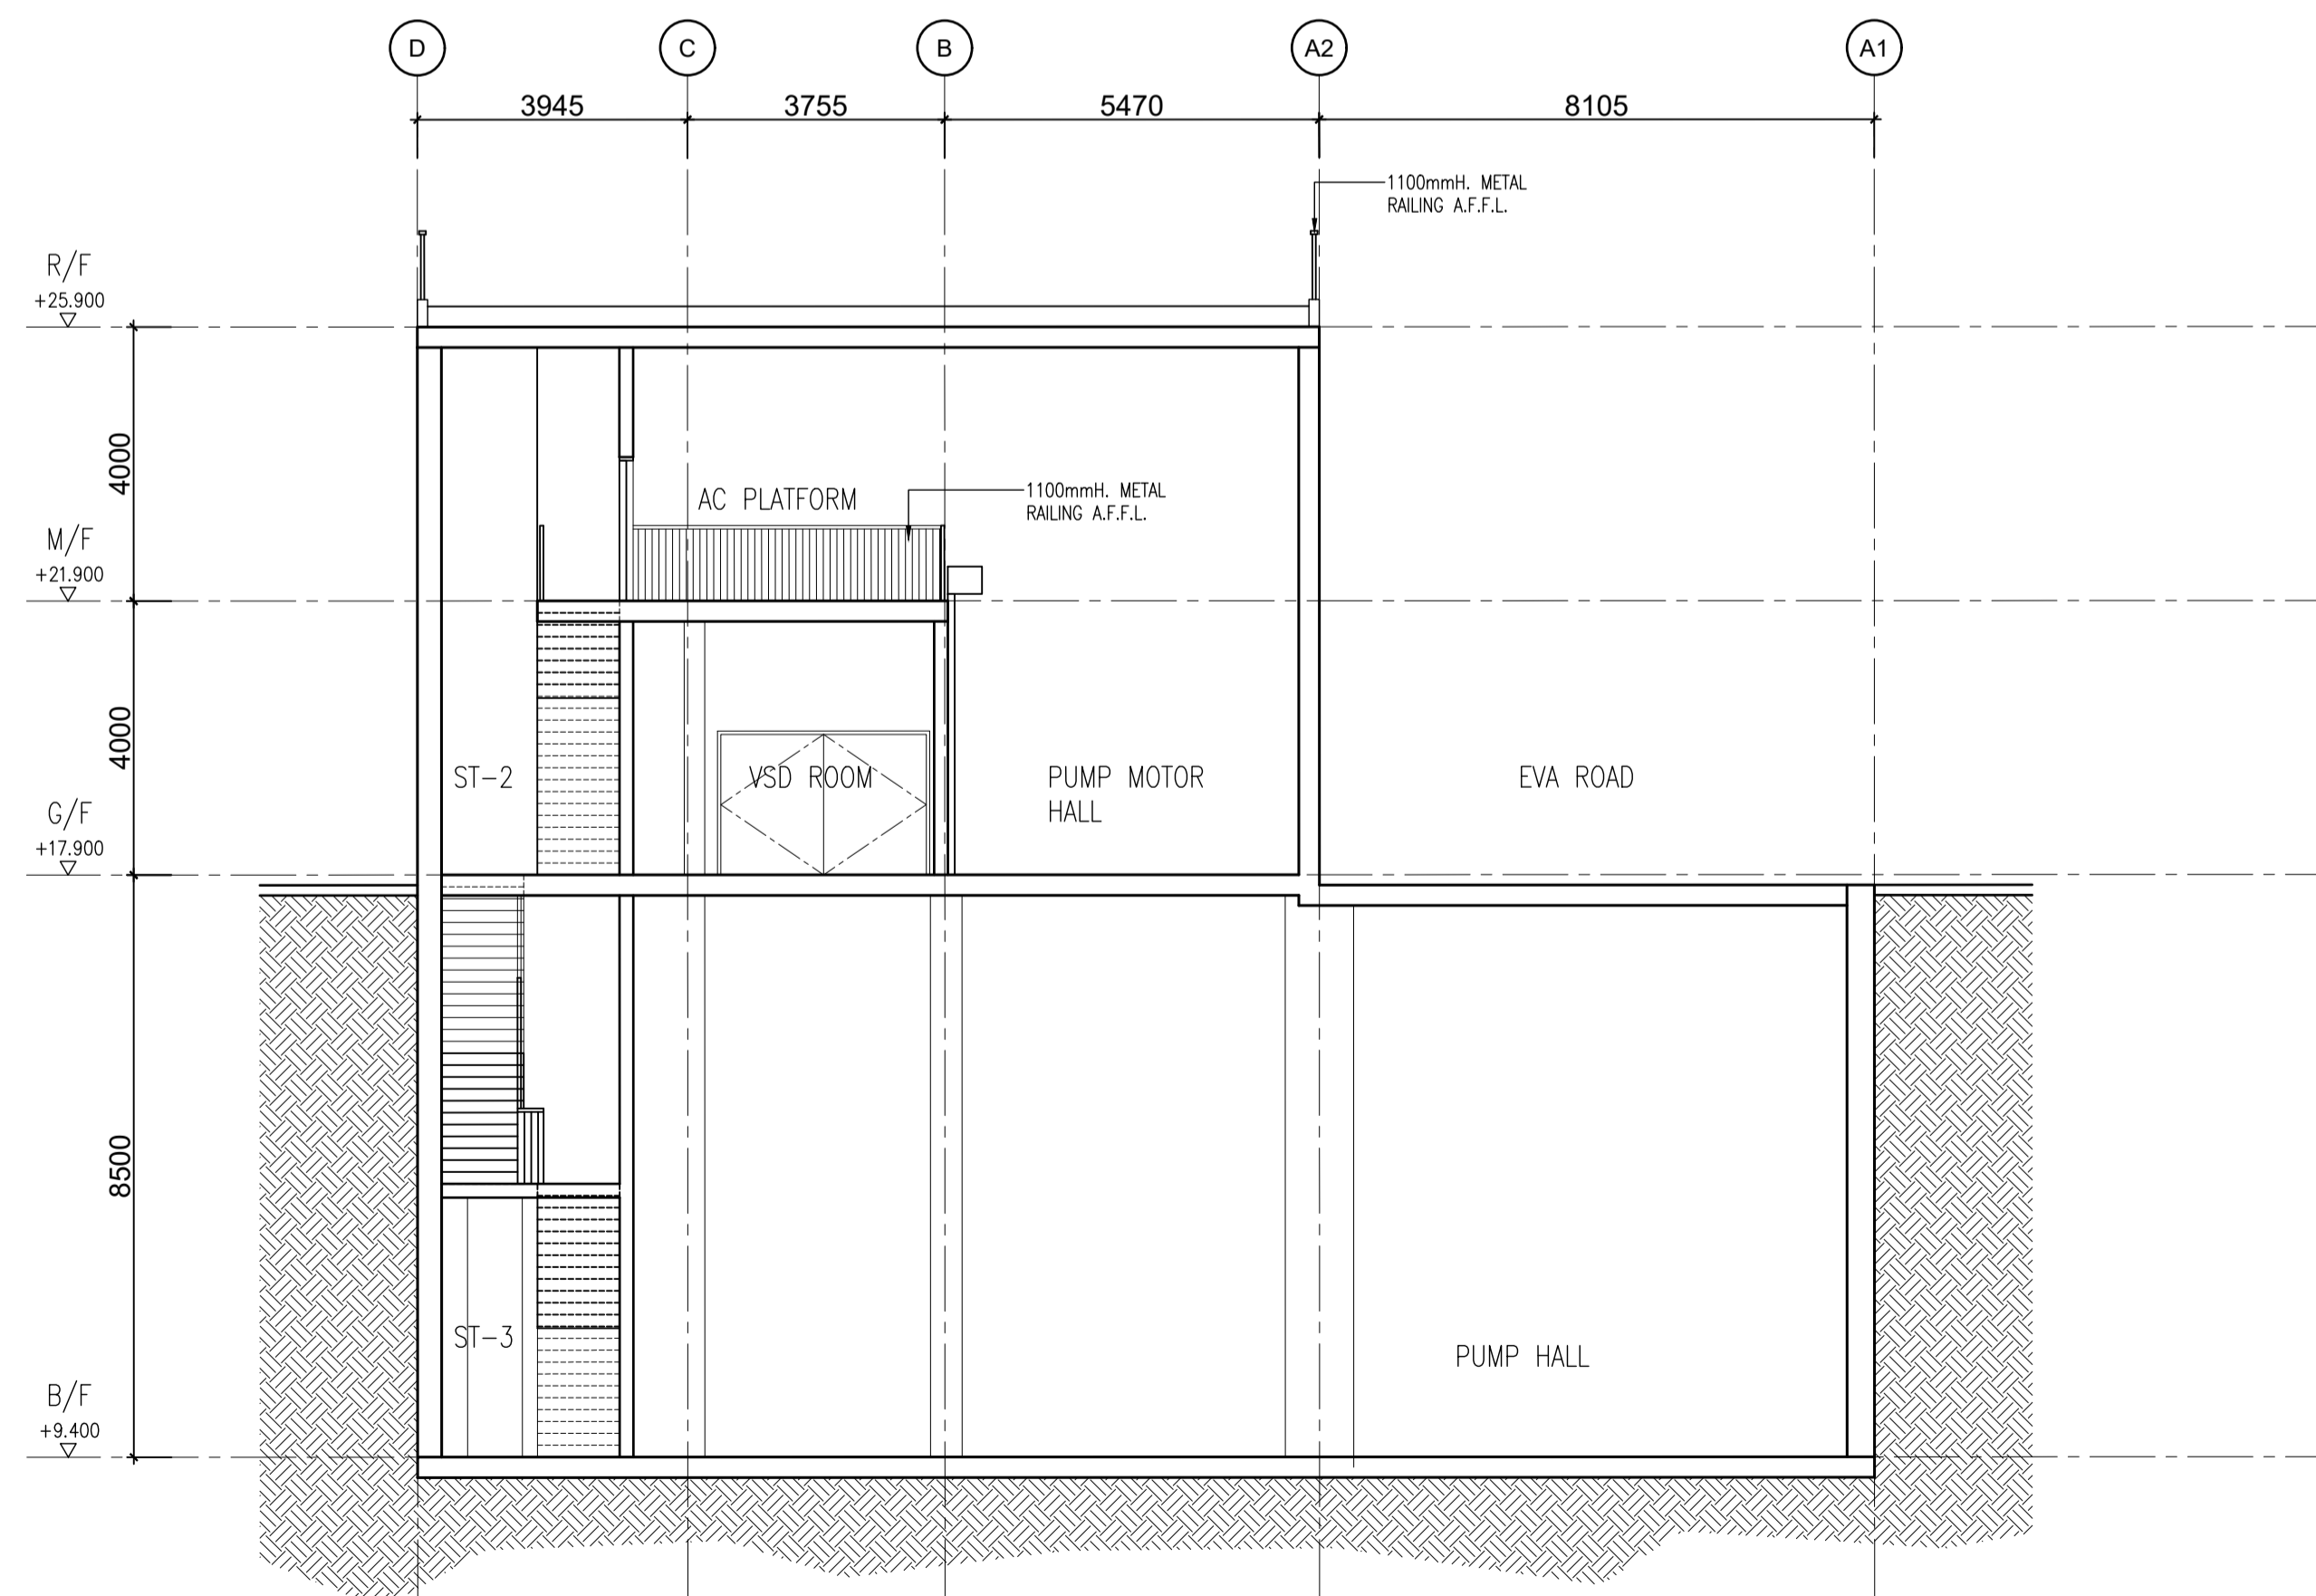

2 SECTION B  
SCALE 1:100@A1

Rev.	Date	Drawn	Description	Checked	Approved
-	XX/12/24	JL	FIRST SUBMISSION		

Employer



水務署  
Water Supplies Department

Project  
AGREEMENT NO. CE47/2023 (WS)  
IMPROVEMENT OF WATER SUPPLY TO  
NORTHERN NEW TERRITORIES  
- INVESTIGATION, DESIGN AND  
CONSTRUCTION

Title  
PUMP BUILDING - SECTIONS

Consultant



Designed	-	Checked	KB
Drawn	JL	Approved	KB
Scale	A1	Status	Rev
1:100		DESIGN	-

Drawing No.  
IWS-GBP-PB-04  
© Copyright reserved