


EX. Ø50 SPR. PIPE FROM OTHER

LAYOUT PLAN

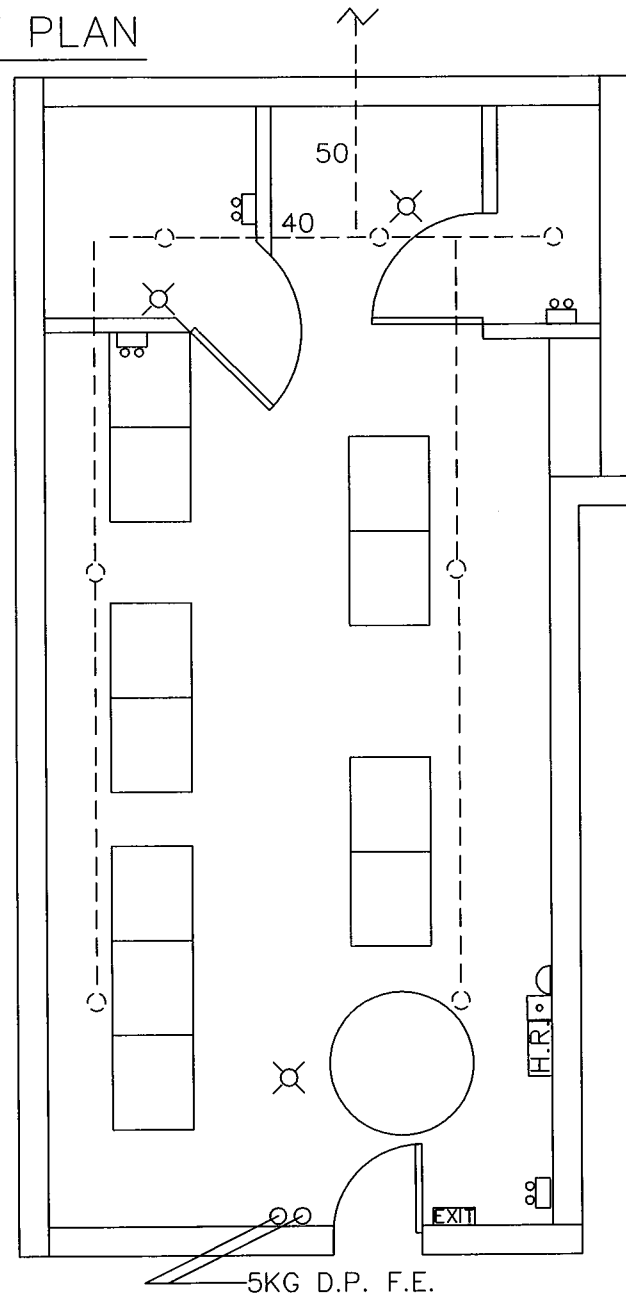


LEGEND

- ⊗ VISUAL FIRE ALARM
- ☼ EXISTING EMERGENCY LIGHT
- EXISTING 68°C SPRINKLER HEAD
- EXIT EXISTING EXIT SIGN
- H.R. EXISTING HOSE REEL
- EXISTING BREAKGLASS UNIT
- ⊖ EXISTING FIRE ALARM BELL
- EXISTING SPRINKLER PIPE
- 5 KG DRY POWDER FIRE EXTINGUISHERS

F.S NOTES

1. THE FIRE SERVICES INSTALLATIONS SHALL COMPLY WITH CODE OF PRACTICE OF HKFSD YEAR APRIL 2012 VERSION UNLESS OTHERWISE STATED
- EXISTING FIRE SERVICE INSTALLATIONS
1. ALL EXISTING APPROVED FIRE SERVICE INSTALLATION SHALL BE RETAINED AND REMAINED UNCHANGED
  2. 1 SET OF EXISTING HOSE REEL SET SHALL BE RETAINED AND REMAINED UNCHANGED.
  3. EXISTING FIRE ALARM SYSTEM(ONE ACTIVATION POINT AND ONE AUDIO WARNING DEVICE LOCATED AT HOSE REEL) SHALL BE RETAINED AND REMAINED UNCHANGED.
  4. SPLIT TYPE AIR CONDITIONERS ARE USED IN THIS PREMISES. NO VAC CUT – OFF IS PROVIDED WITHIN THE AREA UNDER THIS APPLICATION.
  5. EXISTING 68°C SPRINKLER HEADS UNDER FLOOR SLAB SHALL BE RETAINED AND REMAINED UNCHANGED
  6. EXISTING EMERGENCY LIGHT SHALL BE RETAINED UNCHANGED.
  7. EXISTING EXIT SIGNS SHALL BE RETAINED AND REMAINED UNCHANGED
  8. ALL SPRINKLER PIPE SHALL BE Ø32mm UNLESS OTHERWISE STATED.
- PROPOSED FIRE SERVICE INSTALLATIONS
1. VISUAL FIRE ALARM SIGNALS SHALL BE PROVIDED FOR THE AREA UNDER THIS APPLICATION

APPLICATION UNIT IN SHADED AREA

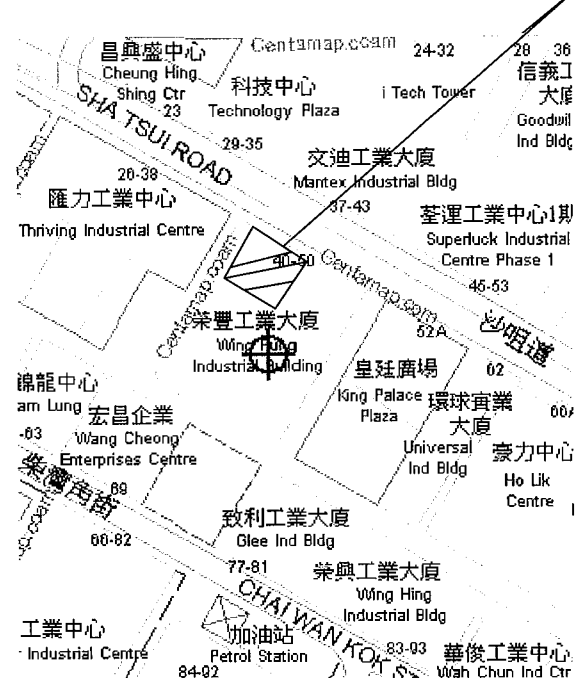

LOCATION PLAN

COLOUR CODE FOR F.S. PIPEWORKS		
NOMINAL PIPE SIZE	COLOUR CODE	COLOUR
Ø32mm	RED	——
Ø40mm	PURPLE	——
Ø50mm	YELLOW	——

CONTRACTOR: 承建  
NEW EXTEND ENG. LTD.  
新展工程有限公司  
Workshop B, 3/F., Chevalier Industrial Building, 45 Beech Street., Tai Kok Tsui, Kowloon.  
TEL: 27892033 FAX: 27892063

TITLE: 圖名  
FIRE SERVICES LAYOUT PLAN

PROJECT: 工程  
F.S. INSTALLATION AT SHOP NO.G52, WING FUNG INDUSTRIAL BLDG., 40 –50 SHA TSUI ROAD, TSUEN WAN

DRAWN BY : 制圖	REX CHAN
CHECKED BY: 校核	
SCALE: 比例	1 : 50
DRAWING NO: 圖號	FS-01
DATE: 日期	15-10-2021